


Outlet Plumbing Section View

Scale 1"=8'

All dimensions and elevations are approximate


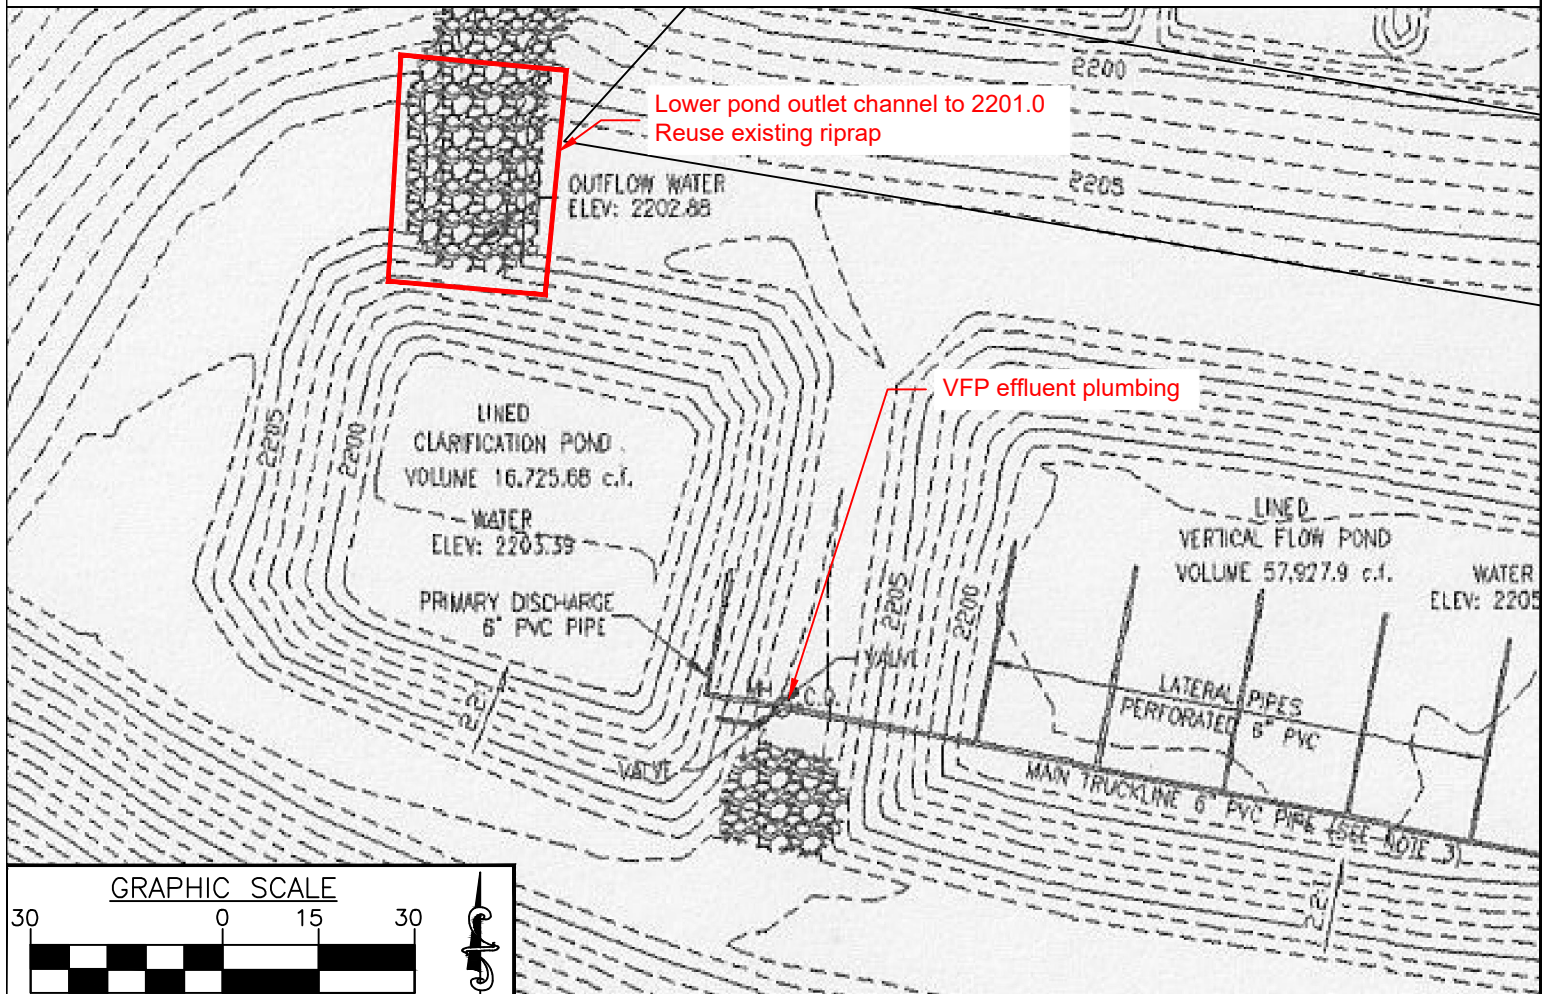


Notes:
Original design plans by: US Environmental Research Service, Altoona, PA
As-built plans prepared by: Benchmark Engineering, Laughlintown, PA

 **HedinEnvironmental**
195 Castle Shannon Blvd.
Pittsburgh, PA 15228
www.hedinenv.com

KL-1 Effluent Plumbing Modification
Klondike Site

Municipality: Dean Twp.	Date: 3/7/22	
COUNTY: Cambria	Drawn by: NAW	Scale: As shown

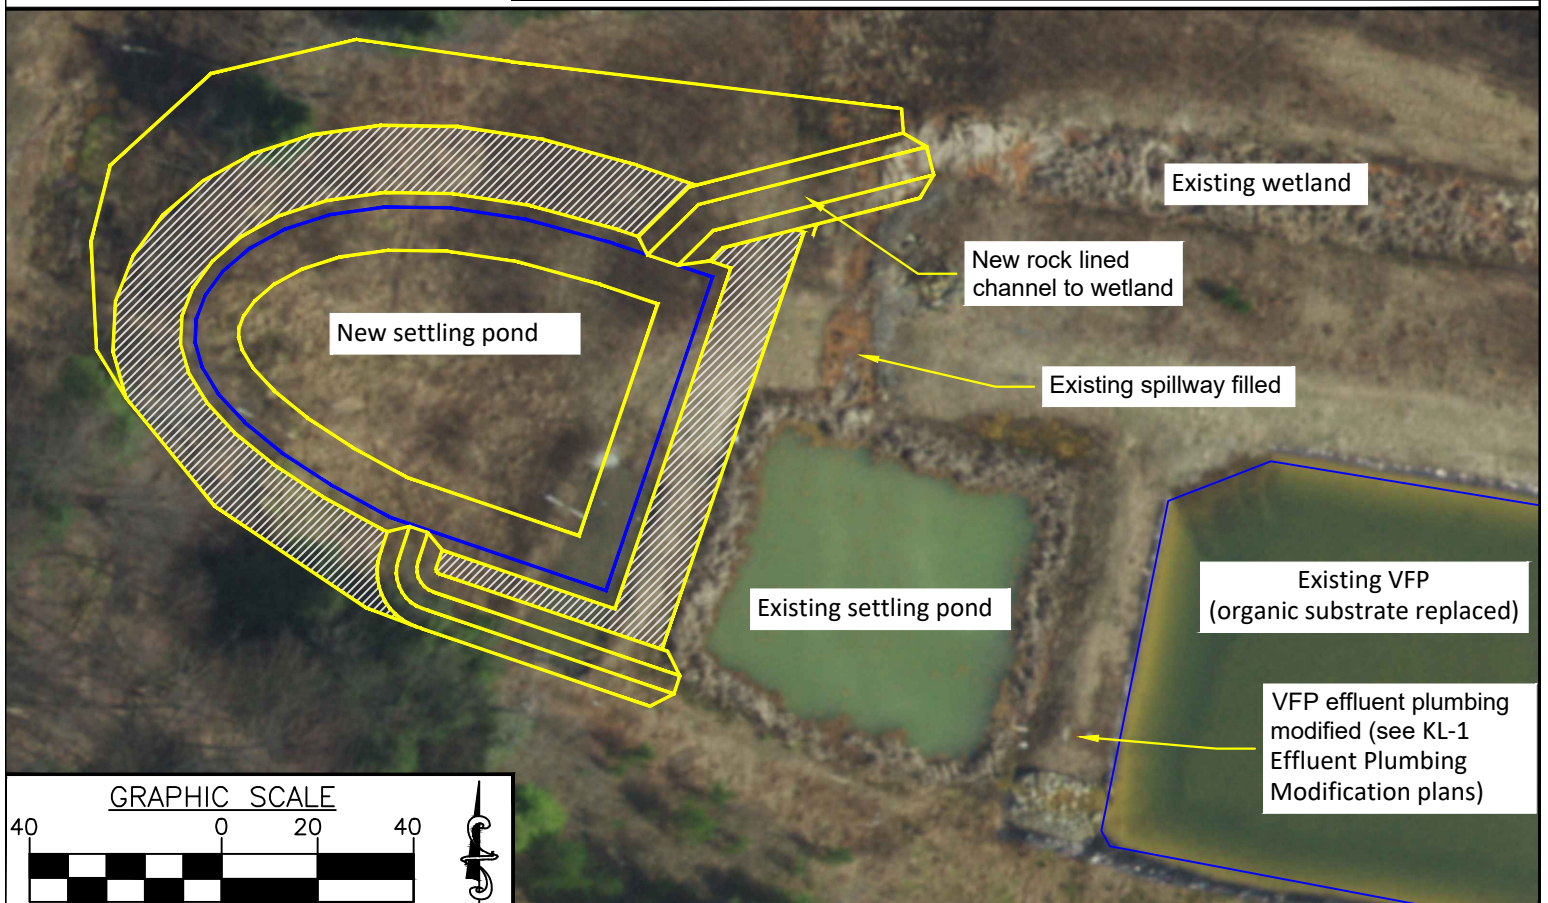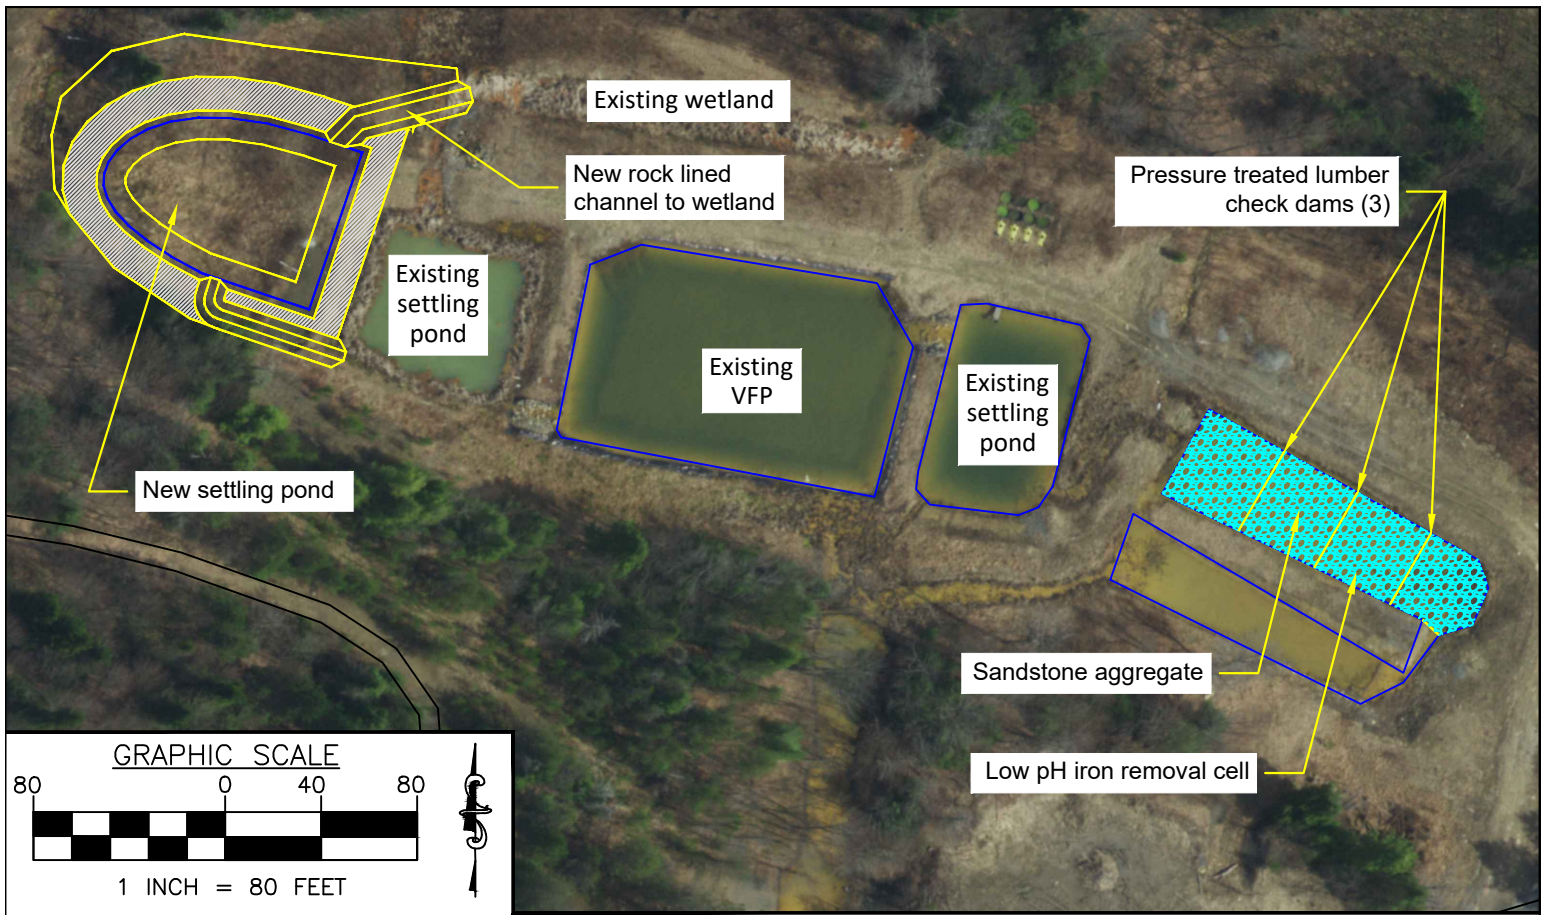


Notes:
 As-built based on plan markup
 Aerial imagery source: PASDA

 **HedinEnvironmental**
 195 Castle Shannon Blvd.
 Pittsburgh, PA 15228
 www.hedinenv.com

KL-1 As-Built Site Plan
 Klondike Site



Municipality: Dean Twp.	Date: 6/30/22	
COUNTY: Cambria	Drawn by: NAW	Scale: As shown

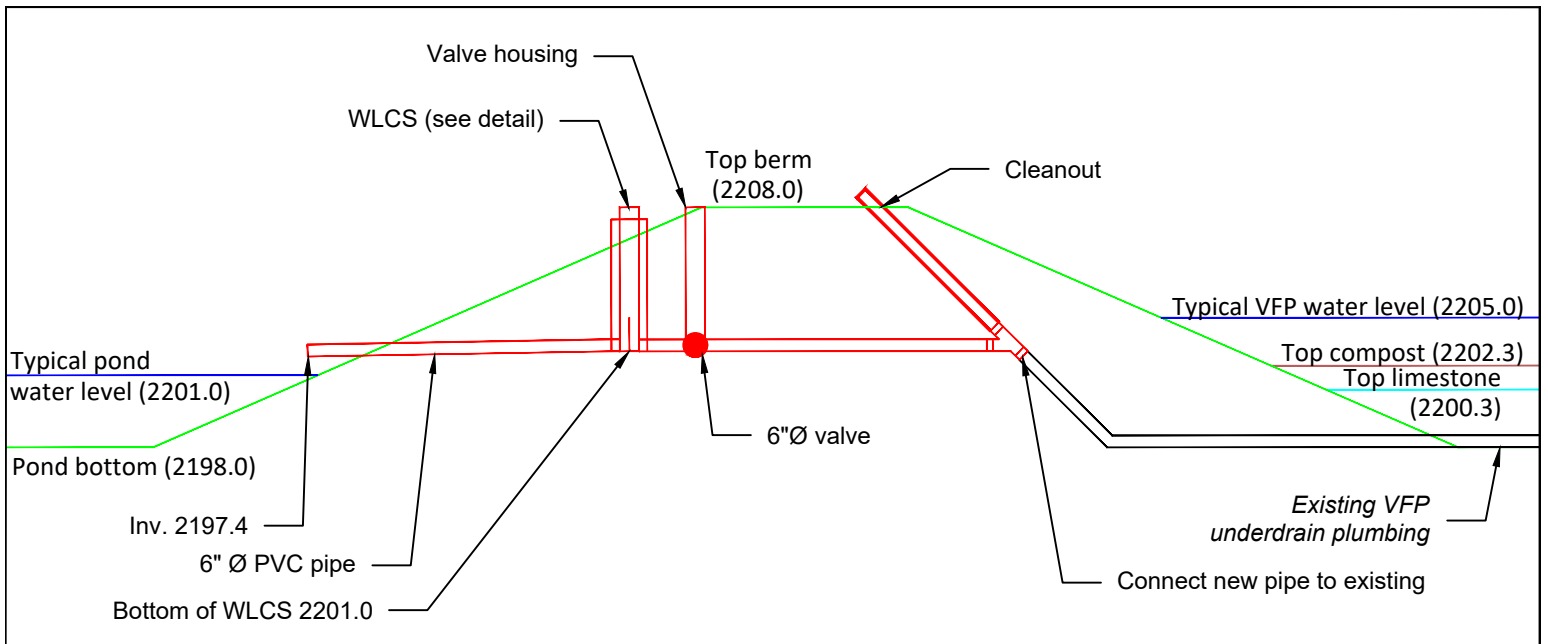


Outlet Plumbing Section View



Scale 1"=8'

All dimensions and elevations are approximate

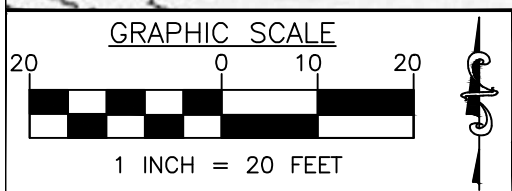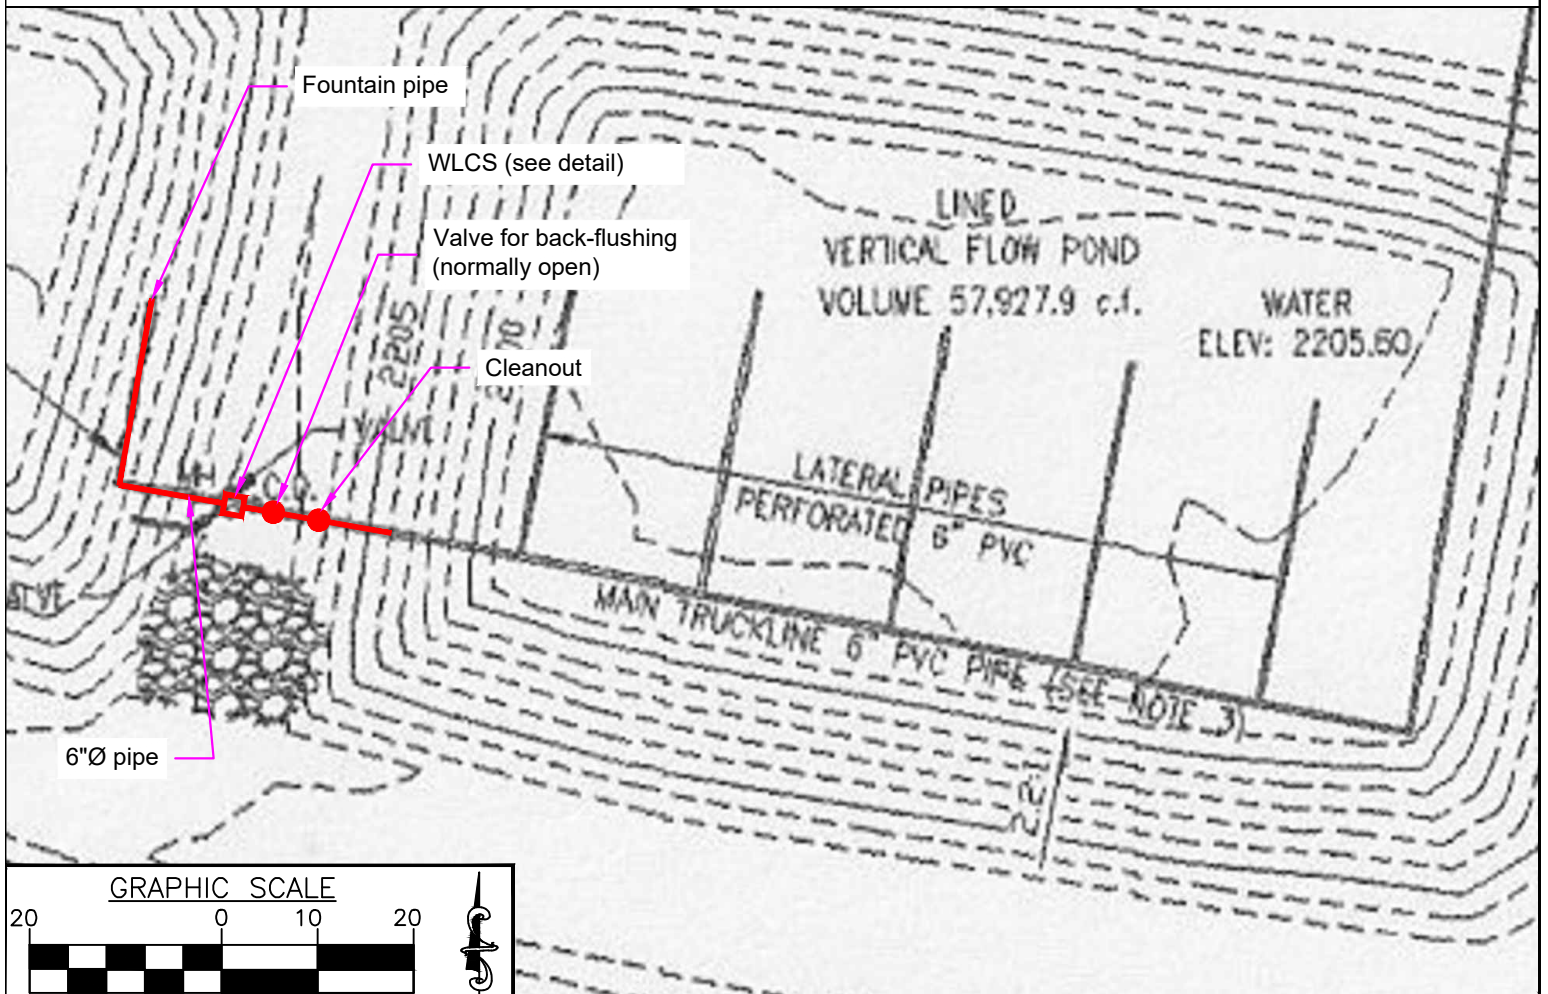

Notes:
Original design plans by: US Environmental Research Service, Altoona, PA
As-built plans based on contractor markup

 HedinEnvironmental 195 Castle Shannon Blvd. Pittsburgh, PA 15228 www.hedinenv.com	KL-1 Effluent Plumbing Mod. As-Built Klondike Site		
	Municipality:	Date:	
	Dean Twp.	6/30/22	
COUNTY:	Drawn by:	Scale:	
Cambria	NAW	As shown	

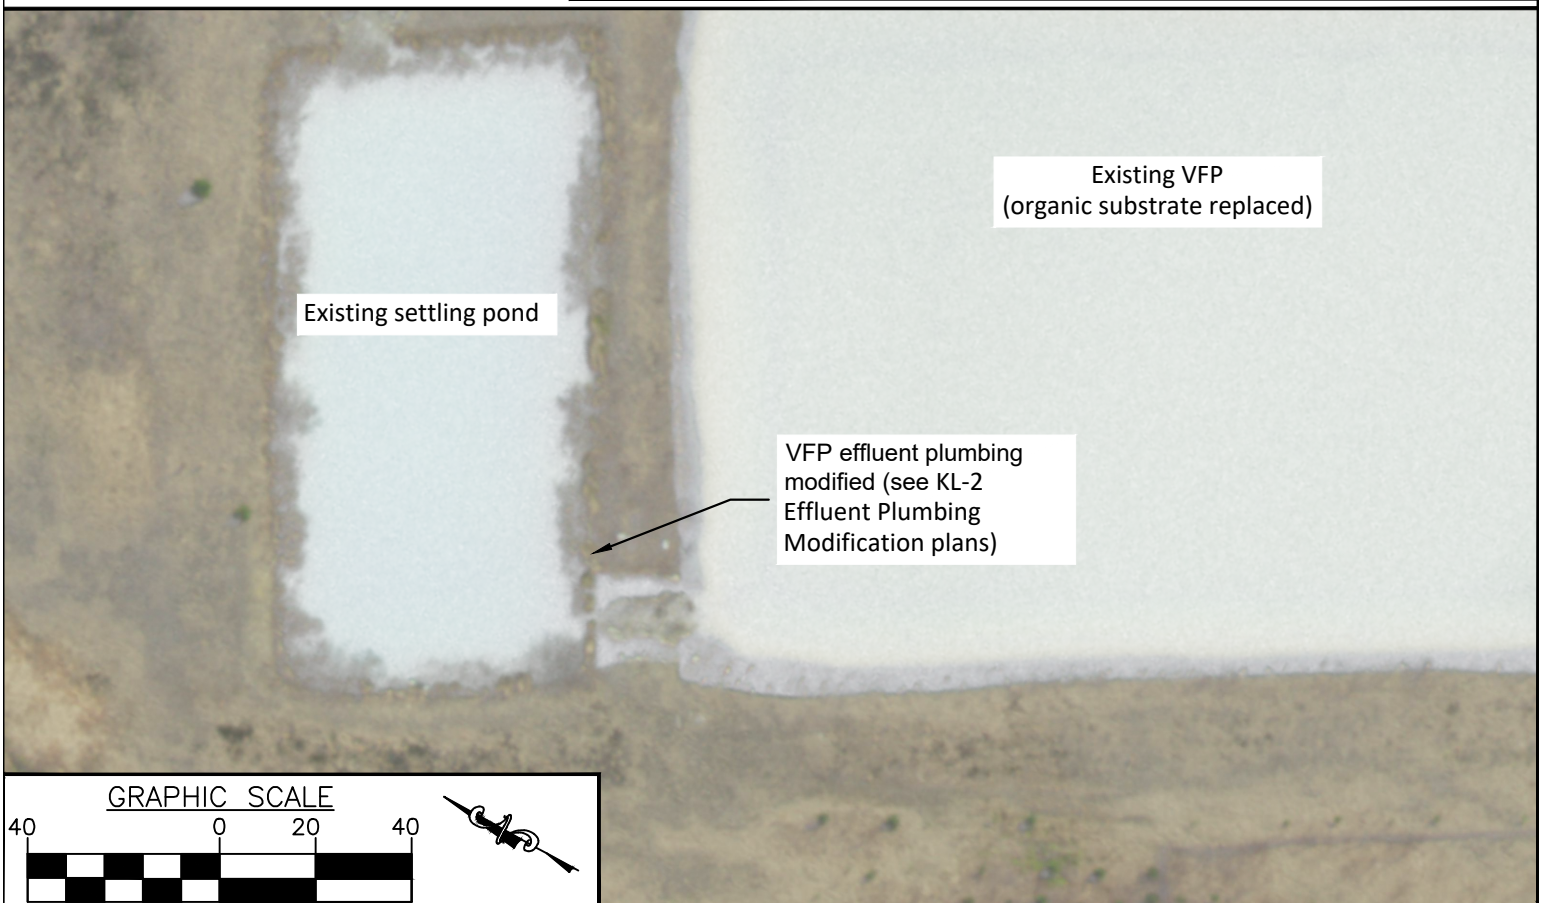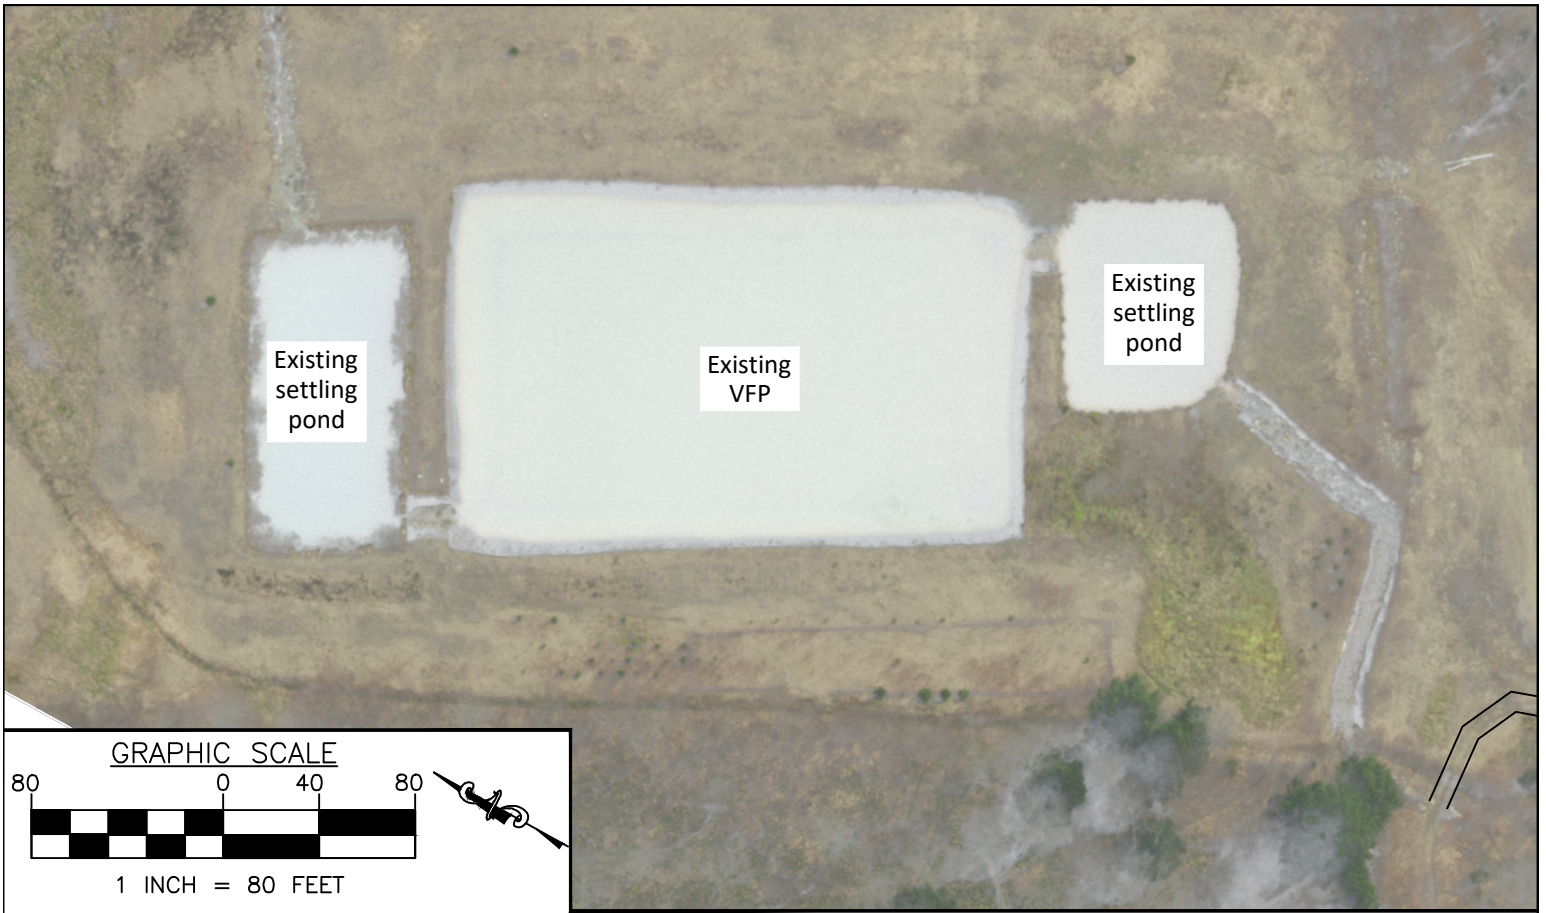

Notes:
As-built based on plan markup
Aerial imagery source: PASDA




HedinEnvironmental

195 Castle Shannon Blvd.
Pittsburgh, PA 15228
www.hedinenv.com

**KL-2 As-Built Site Plan
Klondike Site**


Municipality: Dean Twp.	Date: 6/30/22	
COUNTY: Cambria	Drawn by: NAW	Scale: As shown

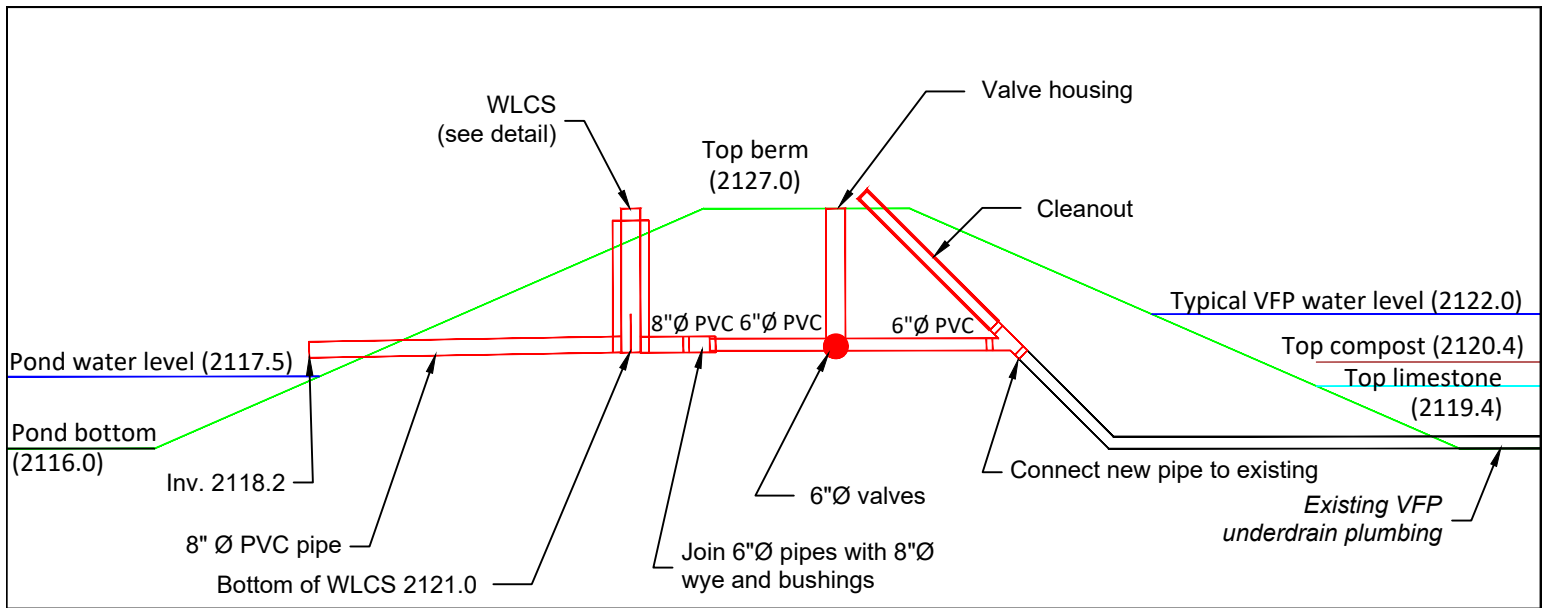


Outlet Plumbing Section View

Scale 1"=8'

All dimensions and elevations are approximate

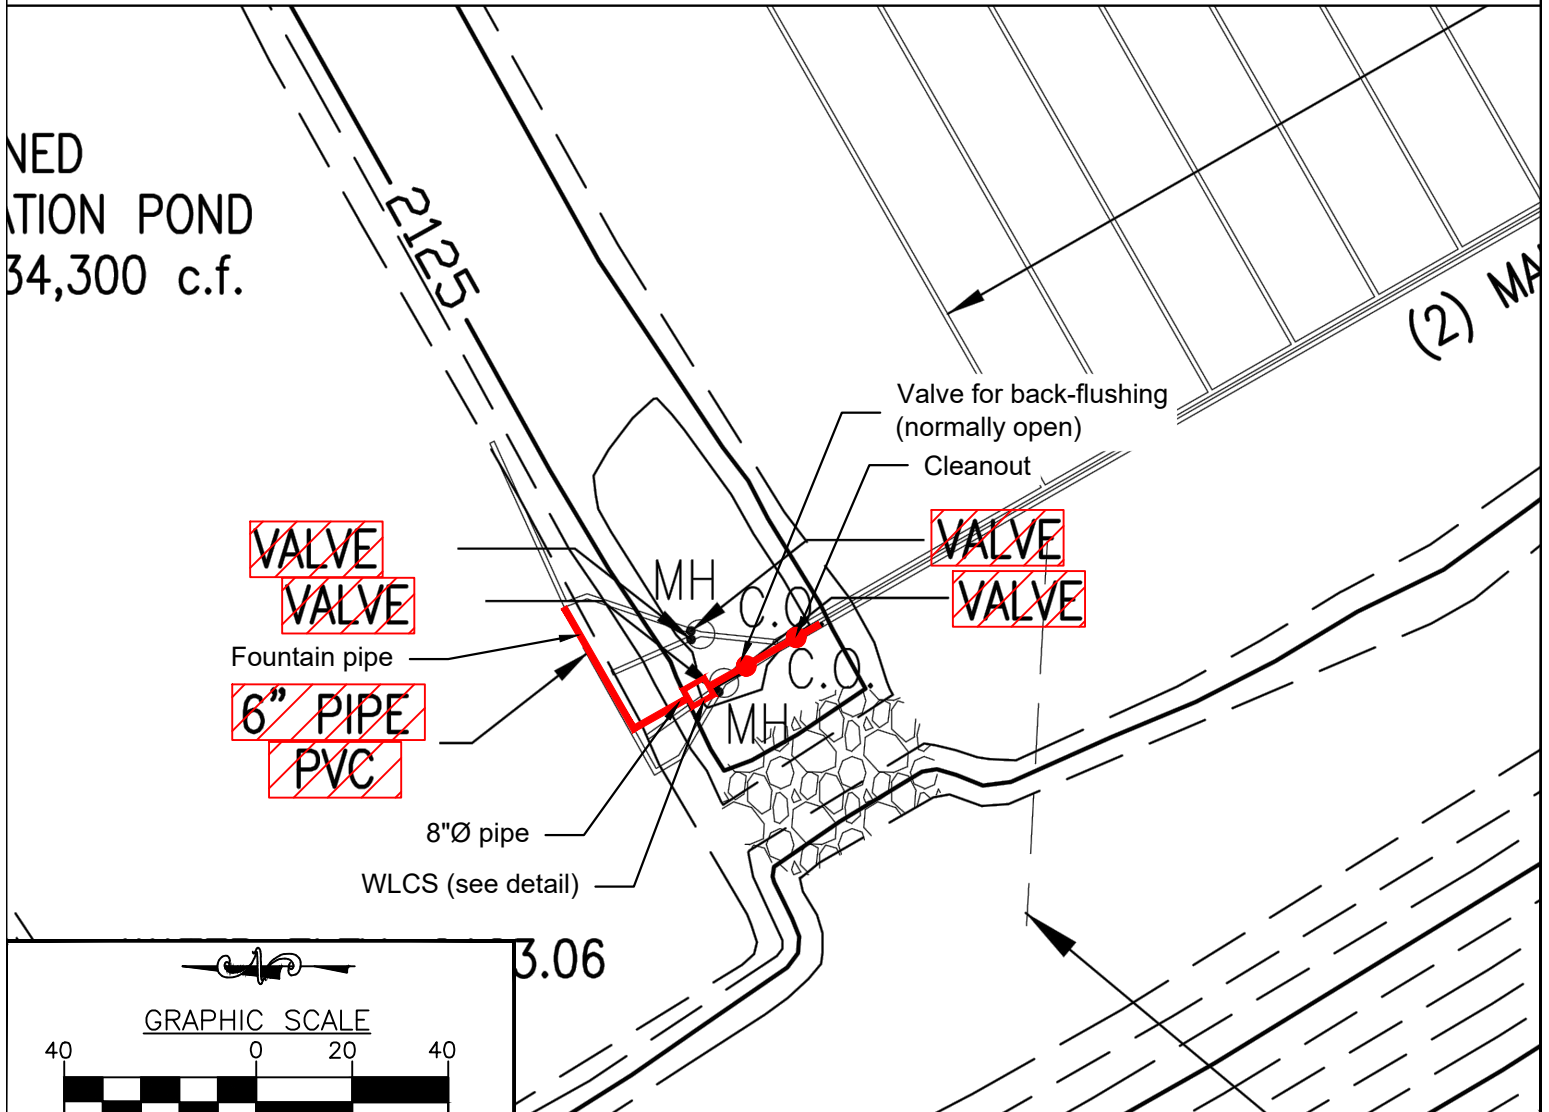

GRAPHIC SCALE

 

1 INCH = 40 FEET





Notes:
 Original design plans by: US Environmental Research Service, Altoona, PA
 As-built plans based on contractor markup



195 Castle Shannon Blvd.
 Pittsburgh, PA 15228
 www.hedinenv.com

**KL-2 Effluent Plumbing Mod. As-Built
 Klondike Site**

Municipality: Dean Twp.	Date: 6/30/22	
COUNTY: Cambria	Drawn by: NAW	Scale: As shown

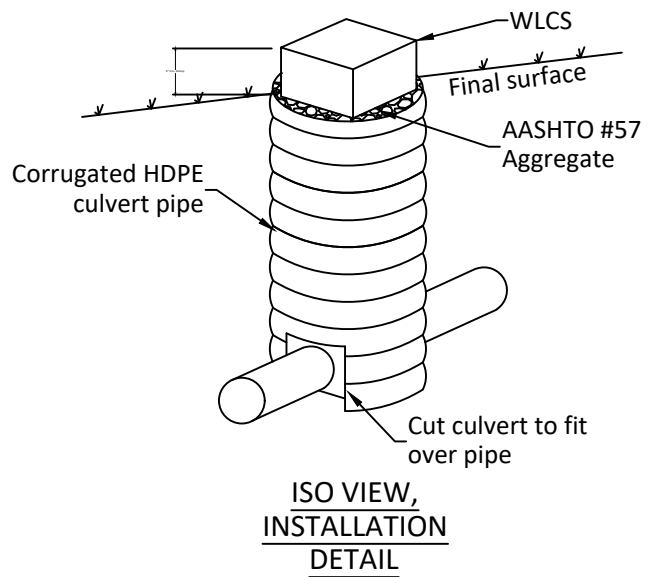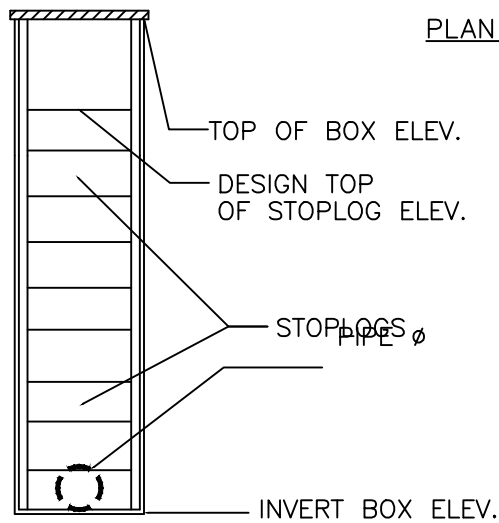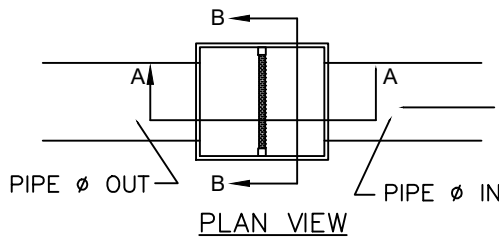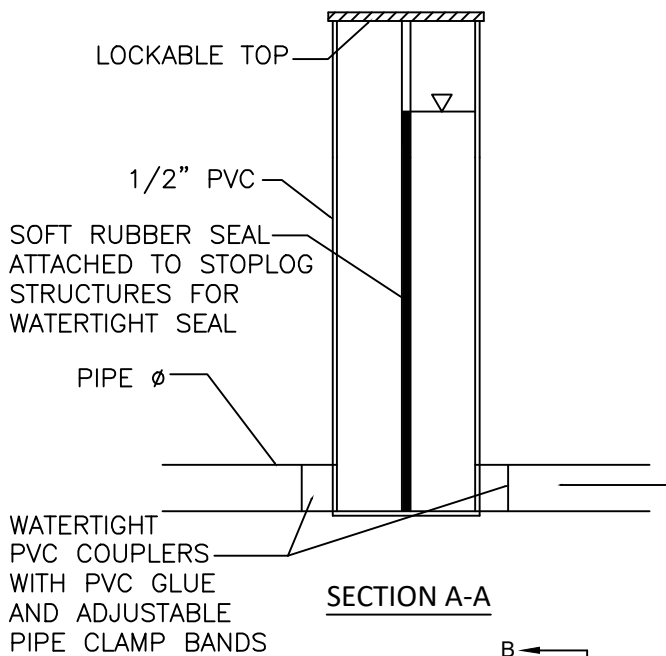

INLINE STRUCTURE	TOP OF BOX ELEV.	INVERT BOX ELEV.	STRUCTURE HEIGHT (FT)	INSIDE DIMENSION WIDTH	INSIDE DIMENSION DEPTH	PIPE Ø (IN)	PIPE TYPE	TOP STOPLOG ELEV.
KL-1	2207.0	2201.0	6	8"	10"	6	PVC	2204.9
KL-2	2127.0	2121.0	6	12"	12"	8	PVC	2122.0

AgriDrain Inline Water Level Control Structure (WLCS)

NO SCALE



HedinEnvironmental

195 Castle Shannon Blvd.
Pittsburgh, PA 15228
www.hedinenv.com

**Water Level Control Structure As-Built
Klondike Site**

Municipality: Dean Twp.	Date: 6/30/22	
COUNTY: Cambria	Drawn by: NAW	Scale: As shown